



Ground Floor - Proposed layout

1:50

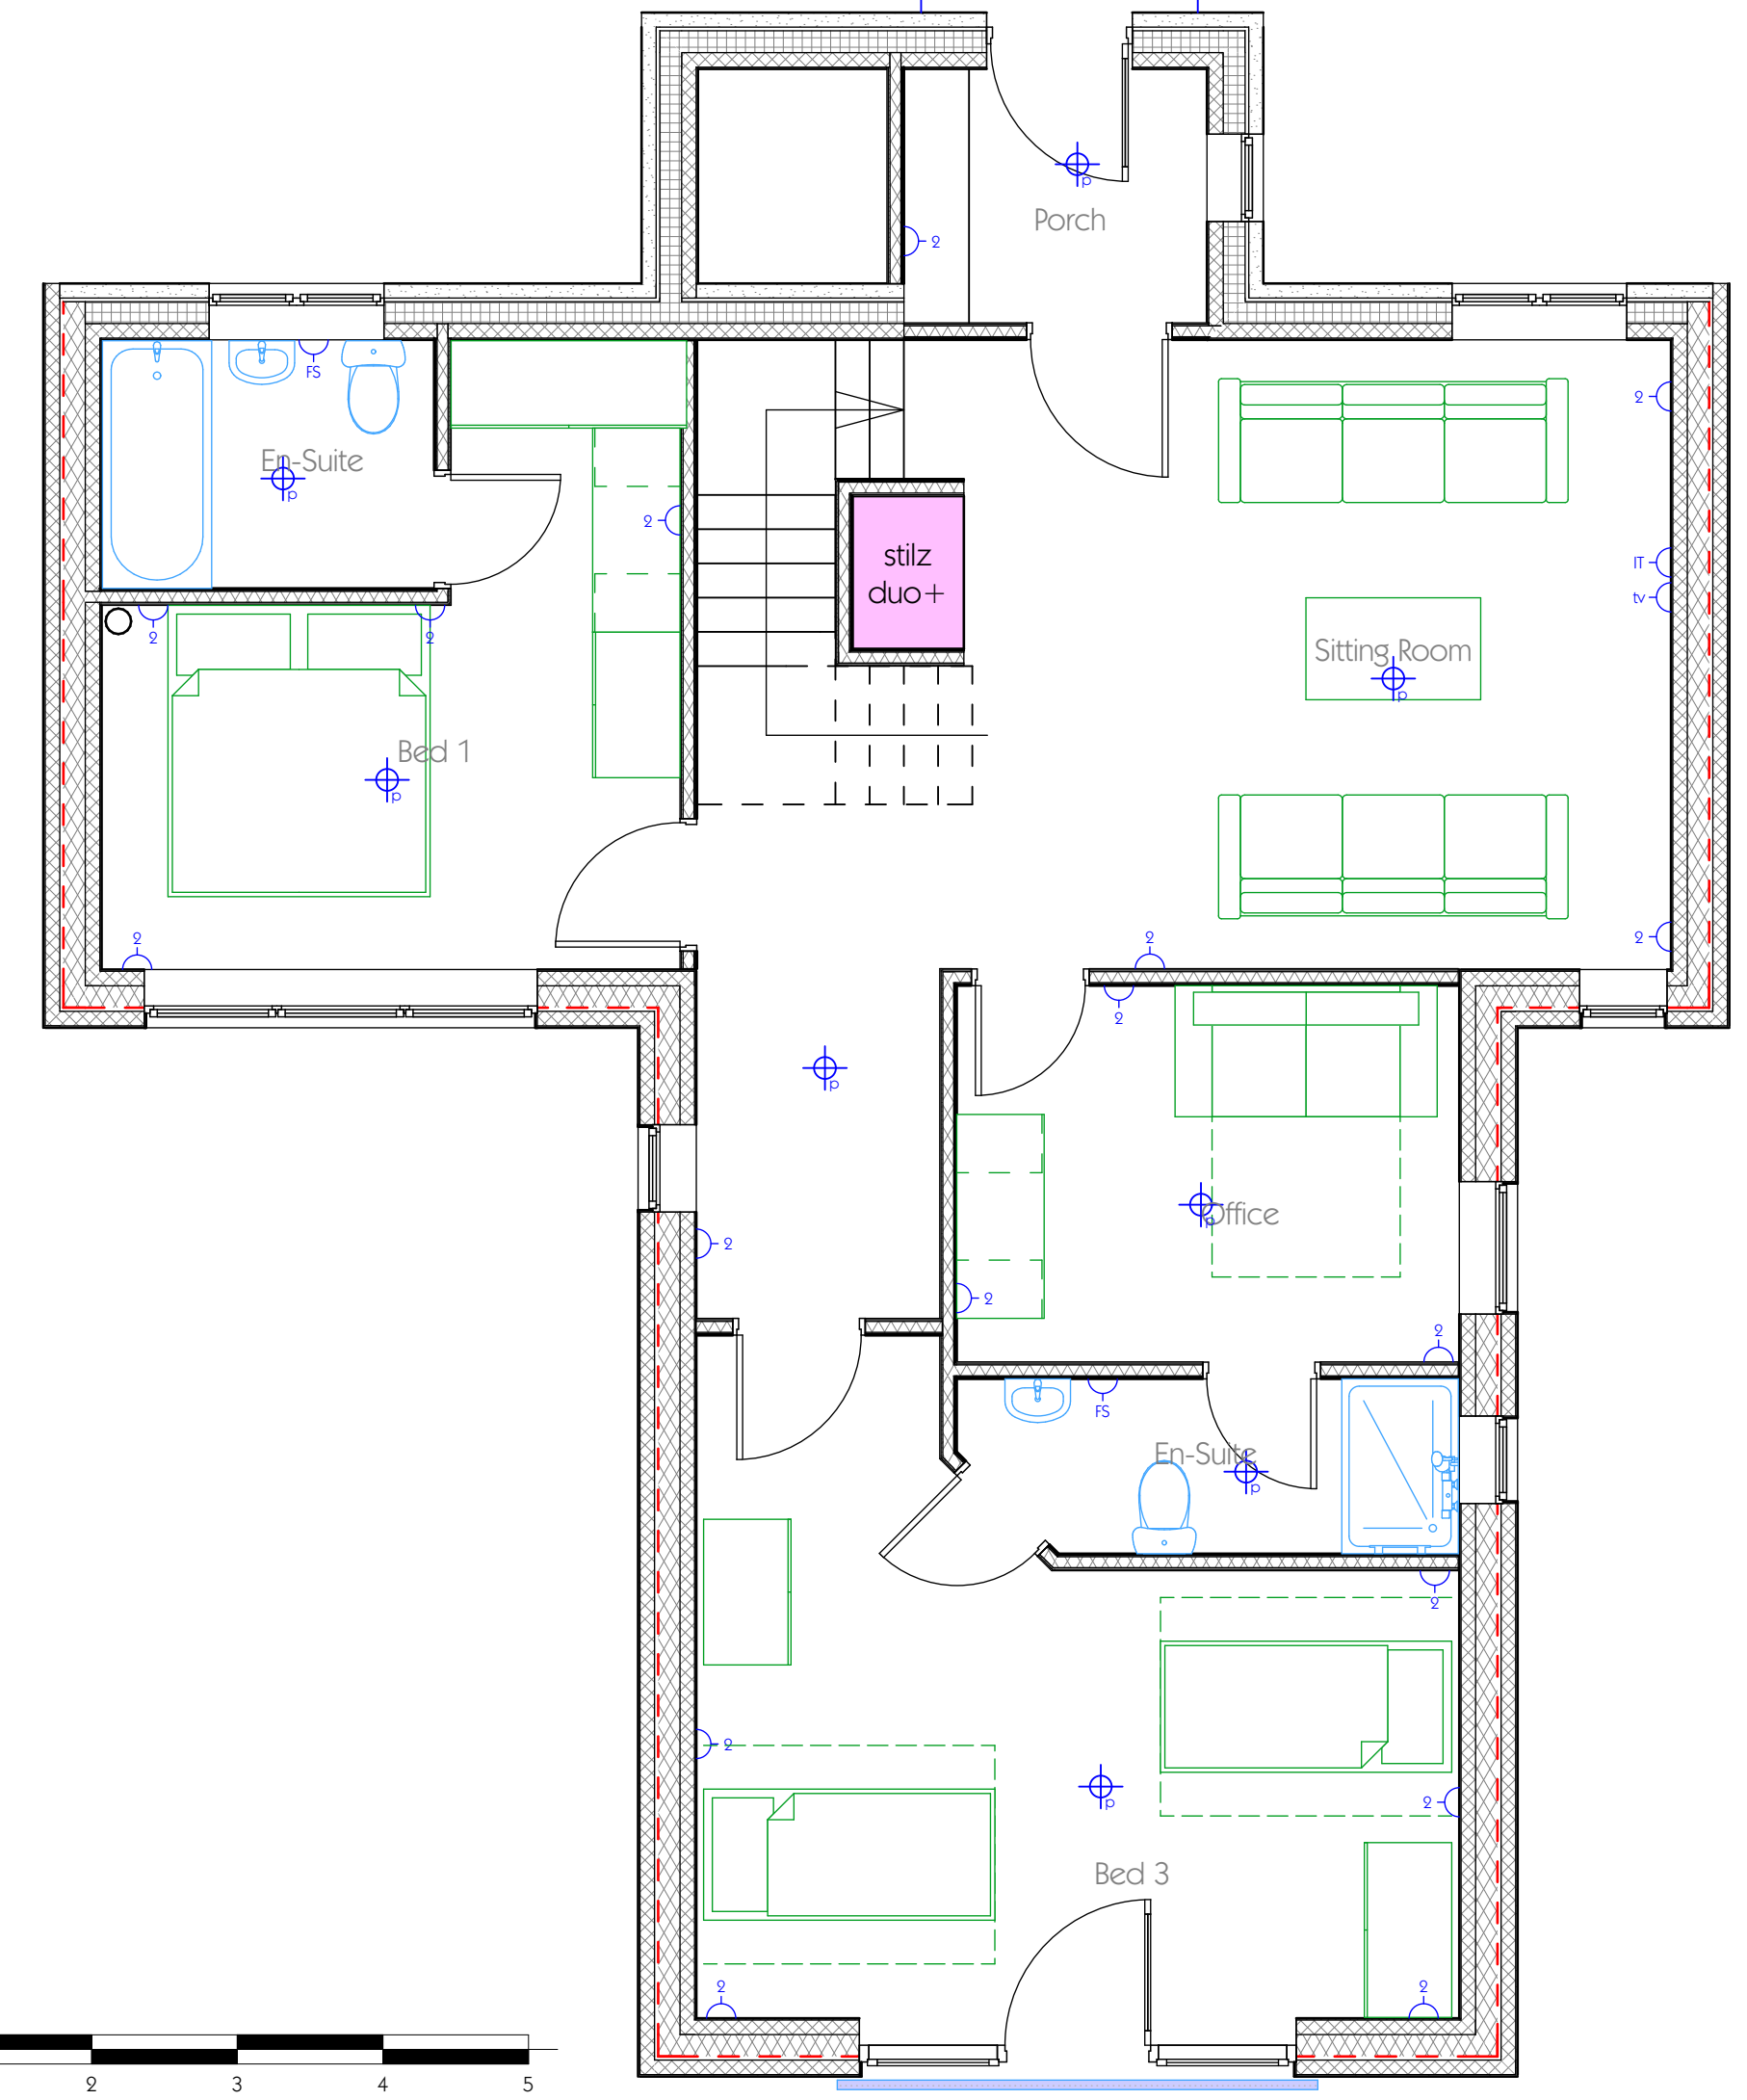


First Floor - Proposed layout

1:50

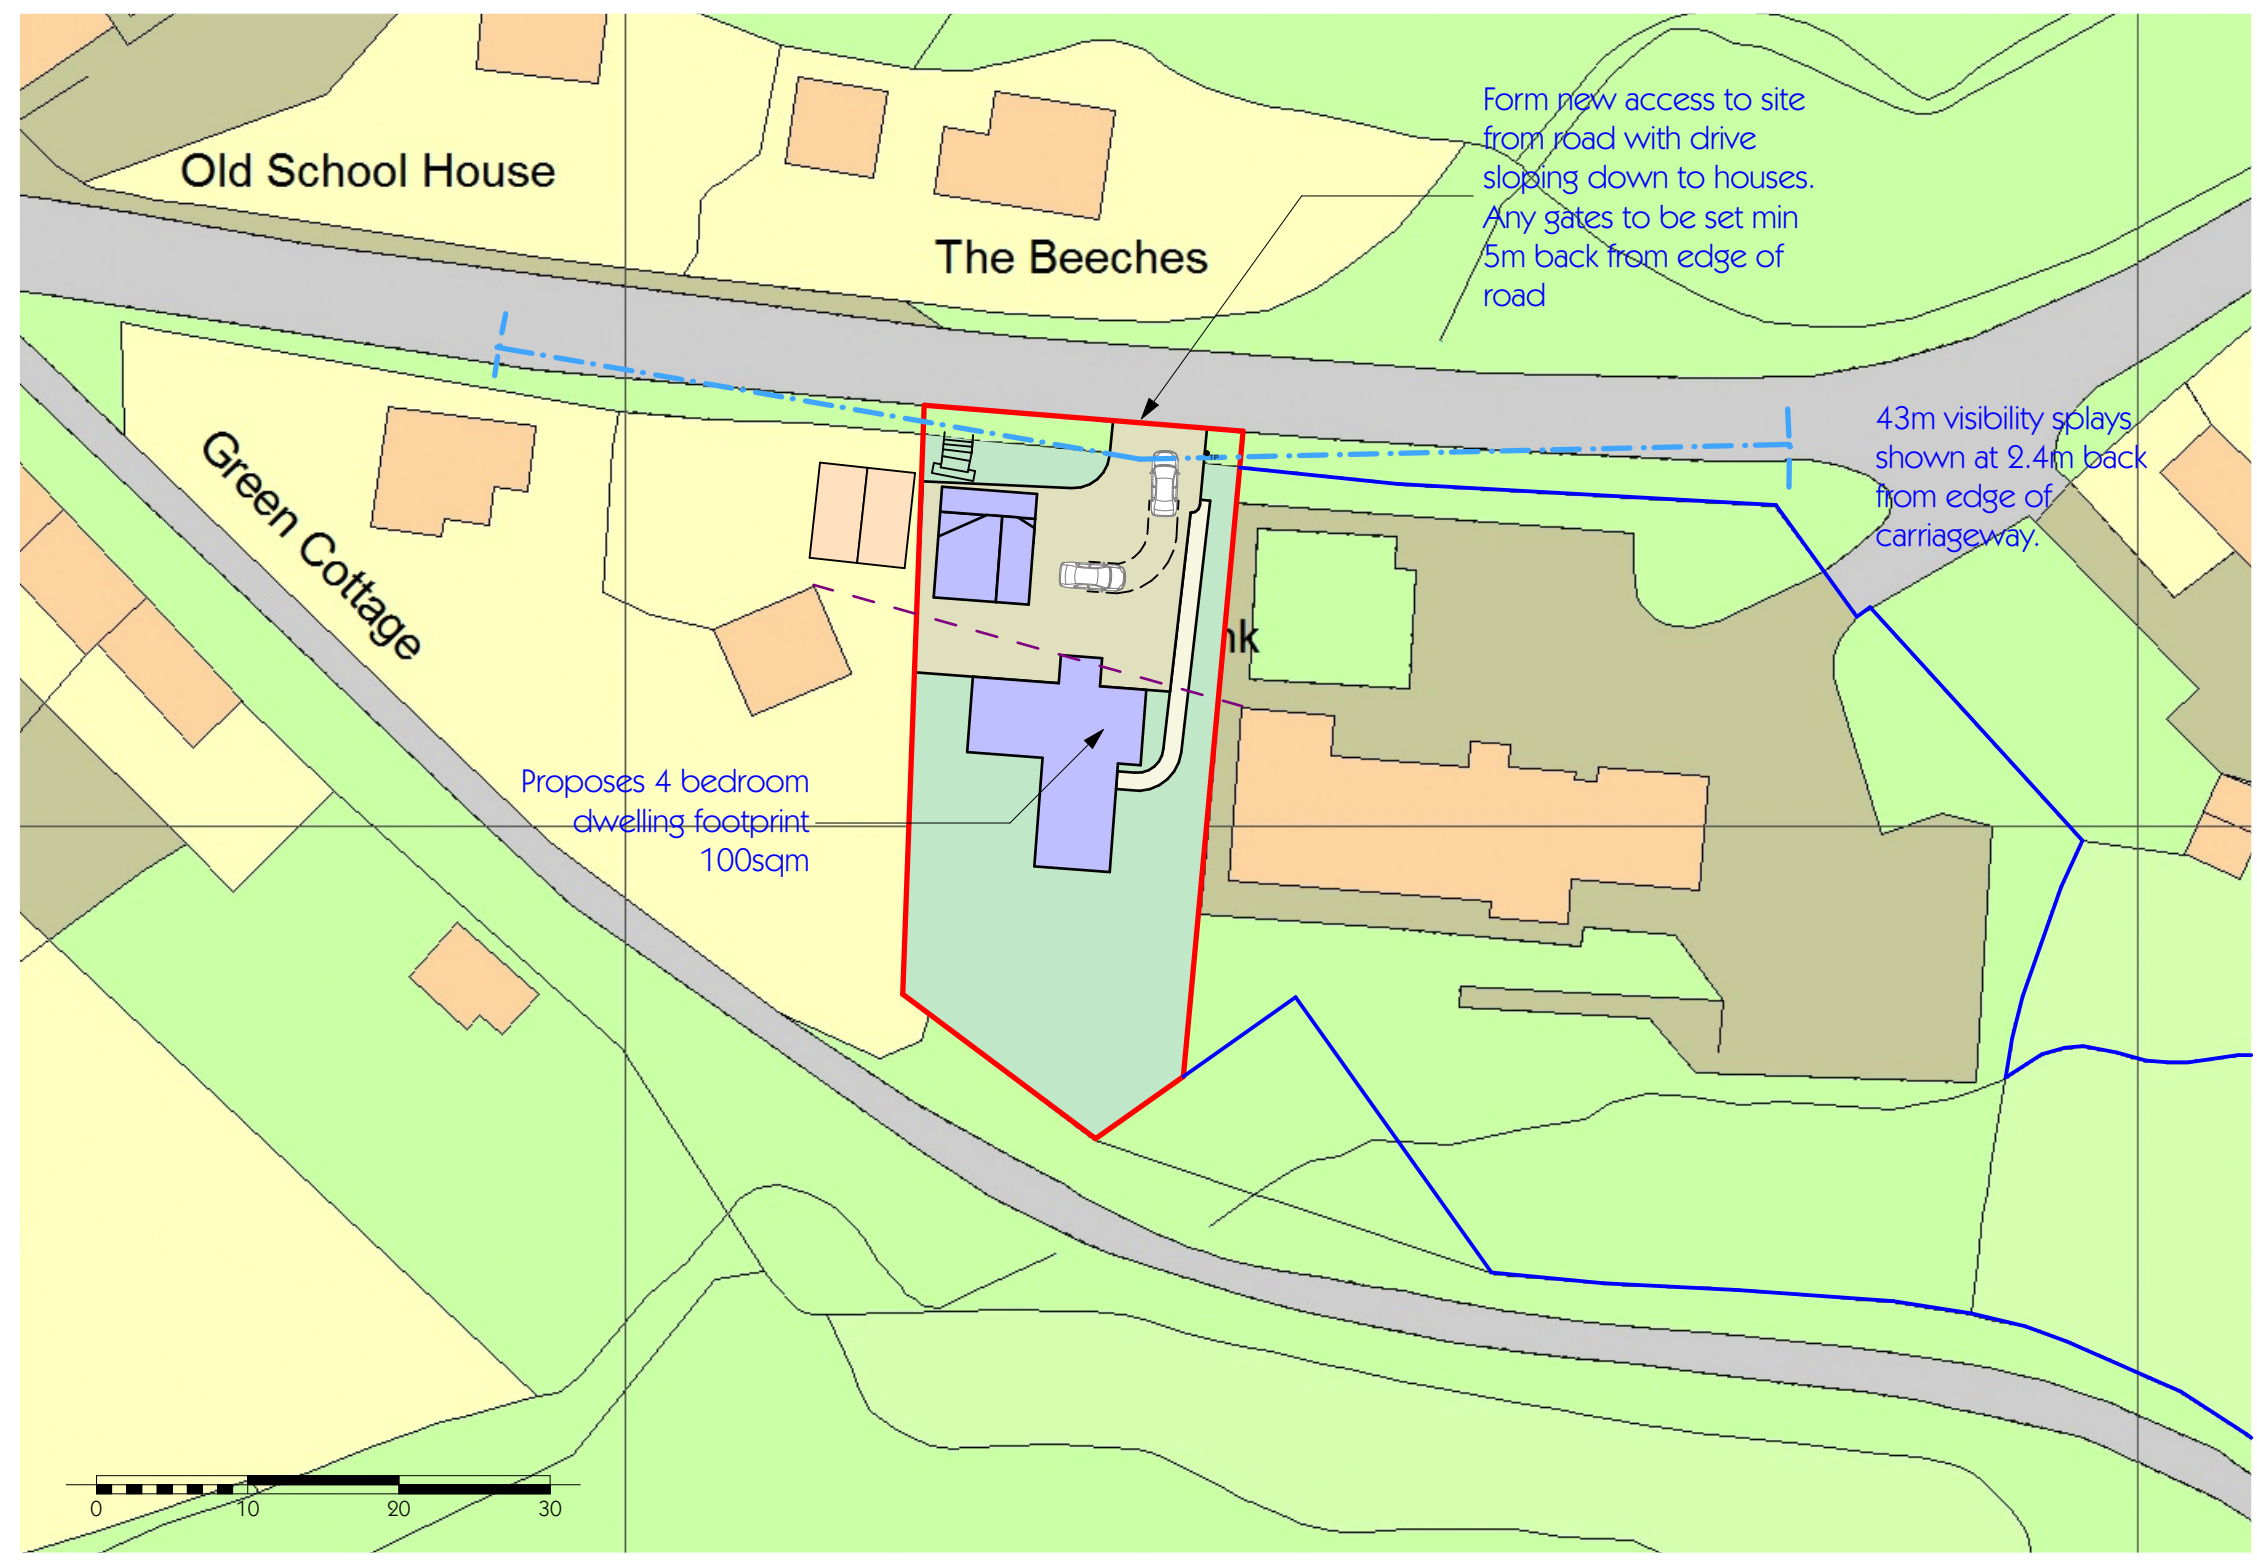


Proposed Block Plan

1:500

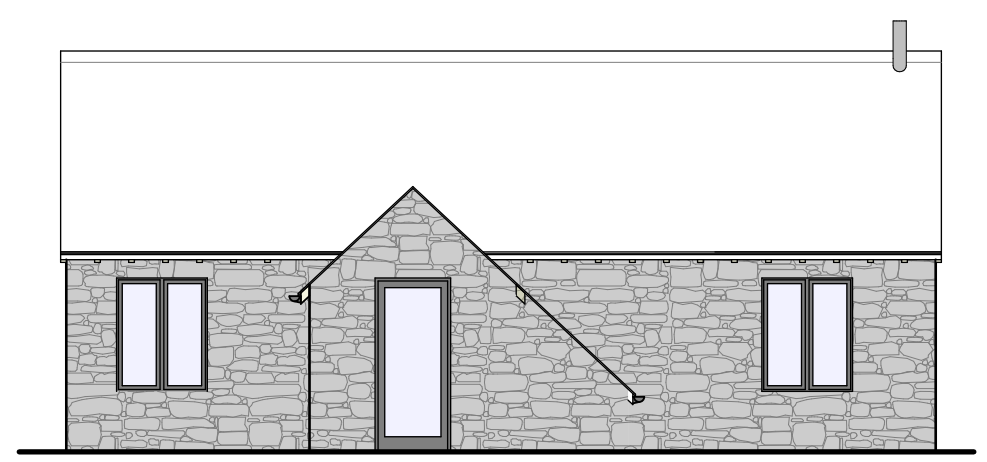


Front (North) Elevation

1:100

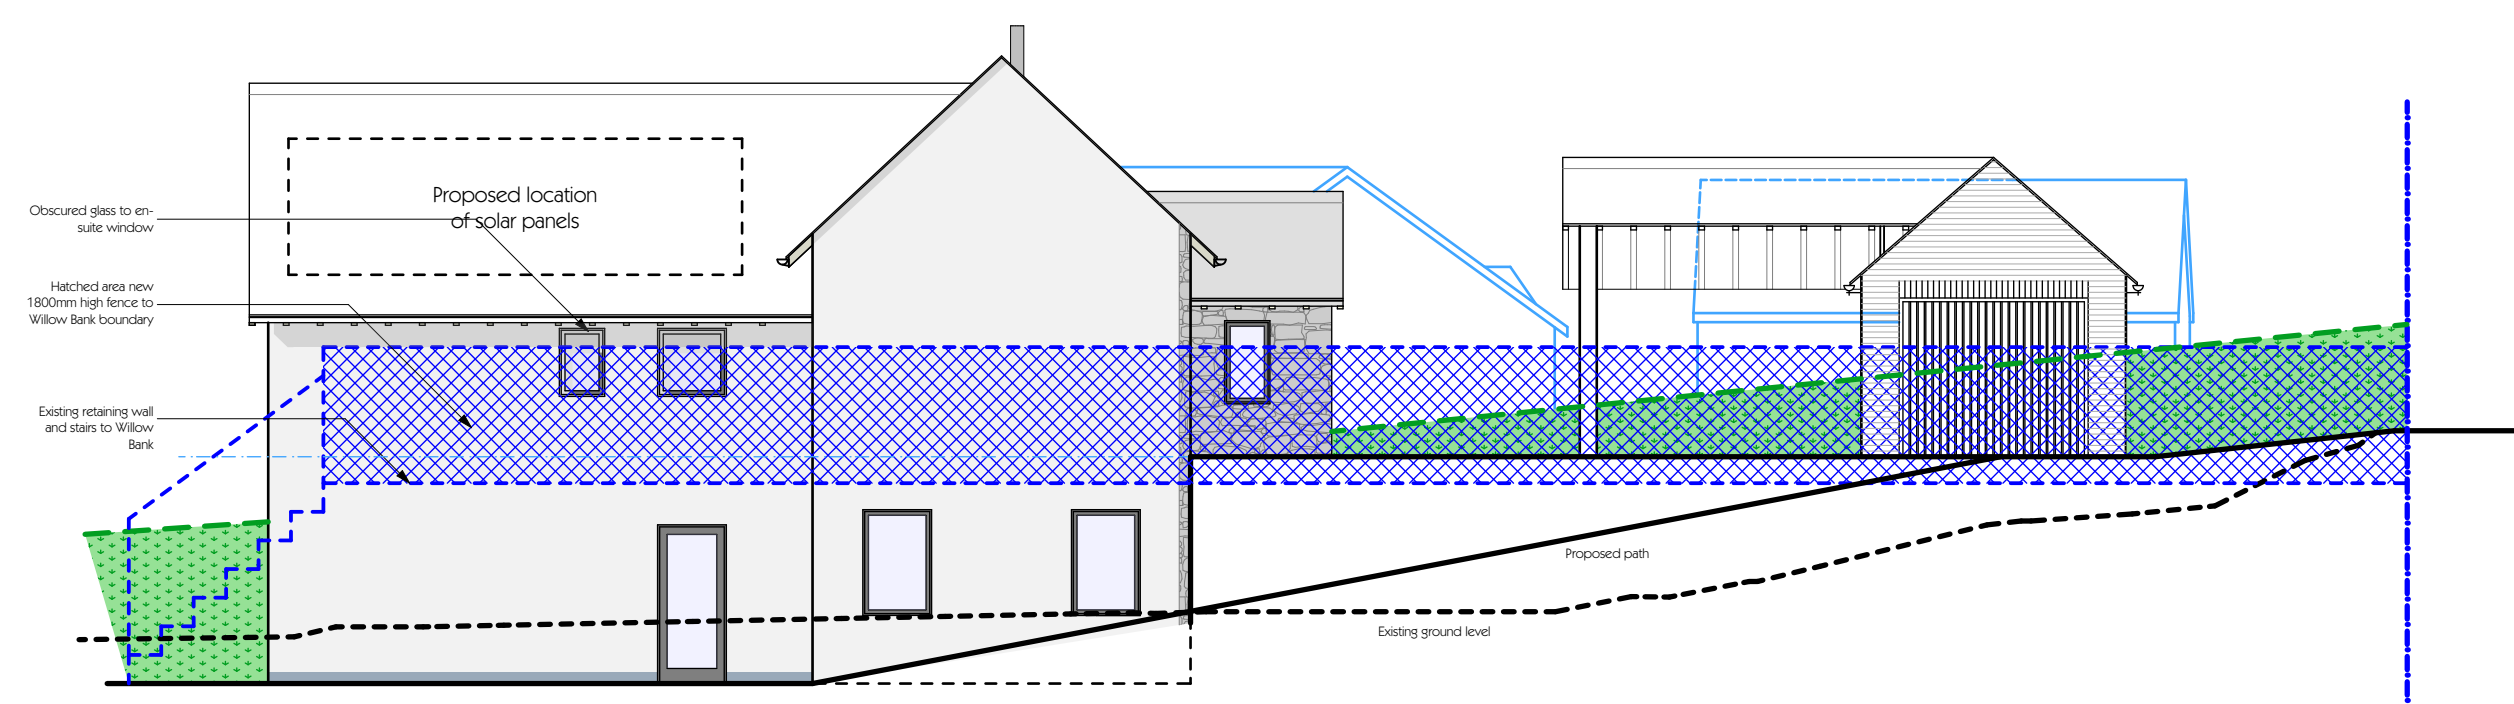

Side (East) Elevation

1:100

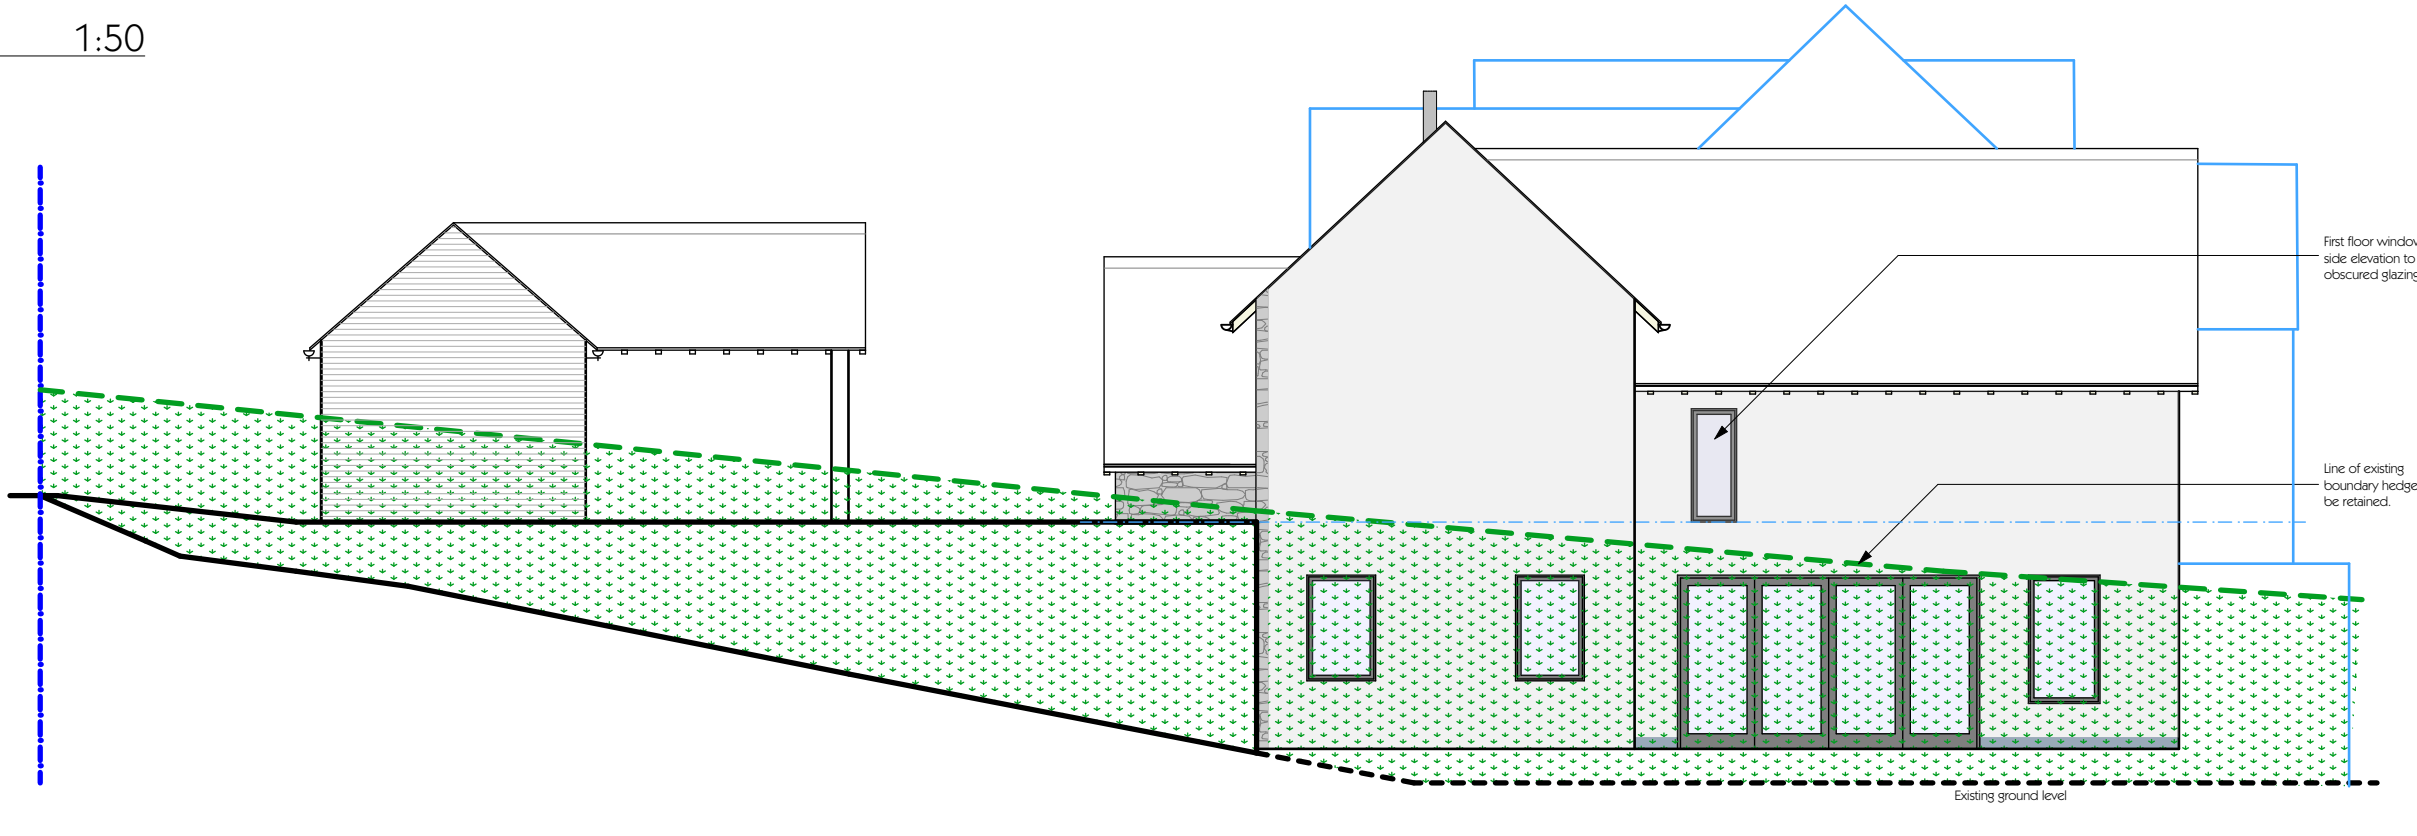


Side (West) Elevation

1:100



3-3

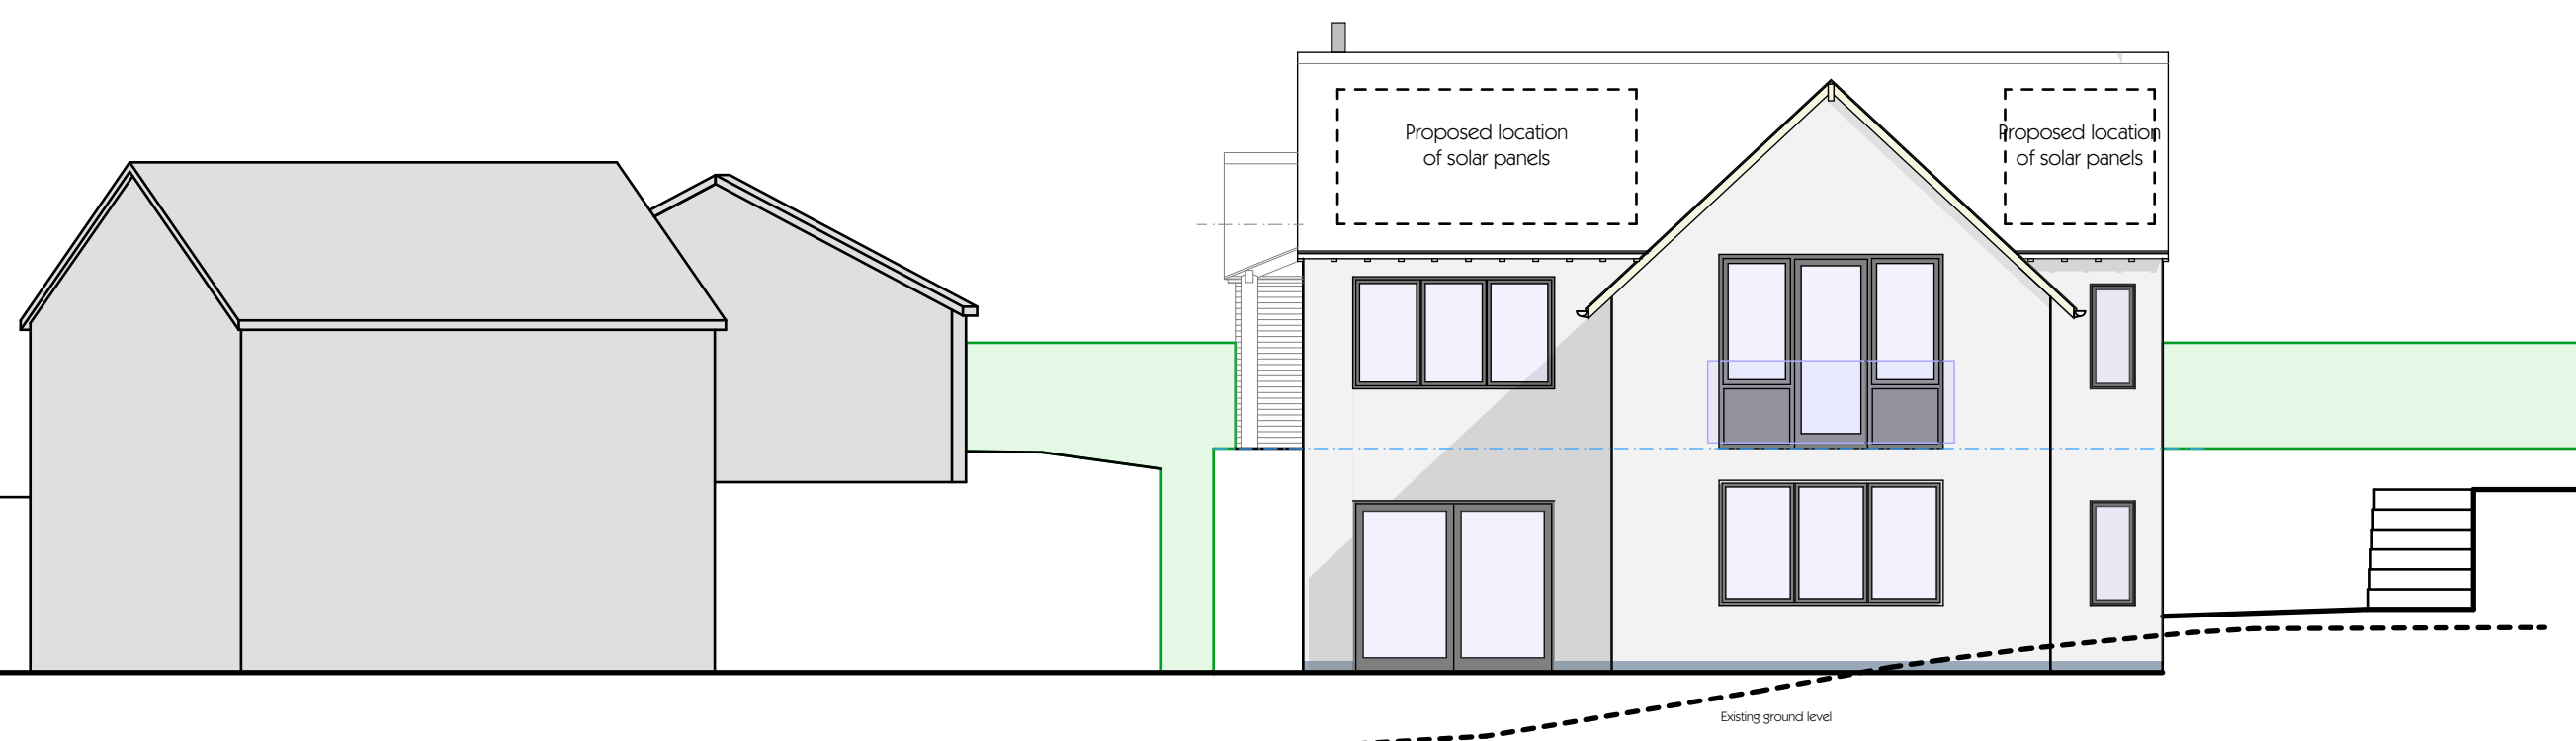

Rear (South) Elevation

1:100

rev	details	by	date
O	Amend porch elevation	cta	08/6/23
N	Add electrical layout	cta	12/5/22
M	Amend path levels	cta	25/4/22
L	Amend rear elevations	cta	16/11/21
K	Amend elevations	cta	11/08/21
J	Amend elevations	cta	10/03/21
H	Amend block plan and elevations	cta	10/03/21
G	Amend elevations	cta	18/02/21
F	Amend south elevation	cta	08/02/21
E	Amend visibility splay	cta	29/01/21
D	Amend side elevations	cta	21/12/20
C	Amend layout	cta	18/12/20
B	Amend elevations	cta	14/12/20
A	Amend layout	cta	6/11/2020

Project	by	date
Vaughan Willow Bank Kniveton		

Drawing Name
Proposed Plans and Elevations - House

Drawn by	Date
cta	Oct 2020

Project No.	Drawing Scale
2019	1:50 & 1:100

Layout ID	Status
050	Construction

Original produced at A1 (841x594) DO NOT SCALE not to reproduce with out written permission of Channel Design Ltd.